


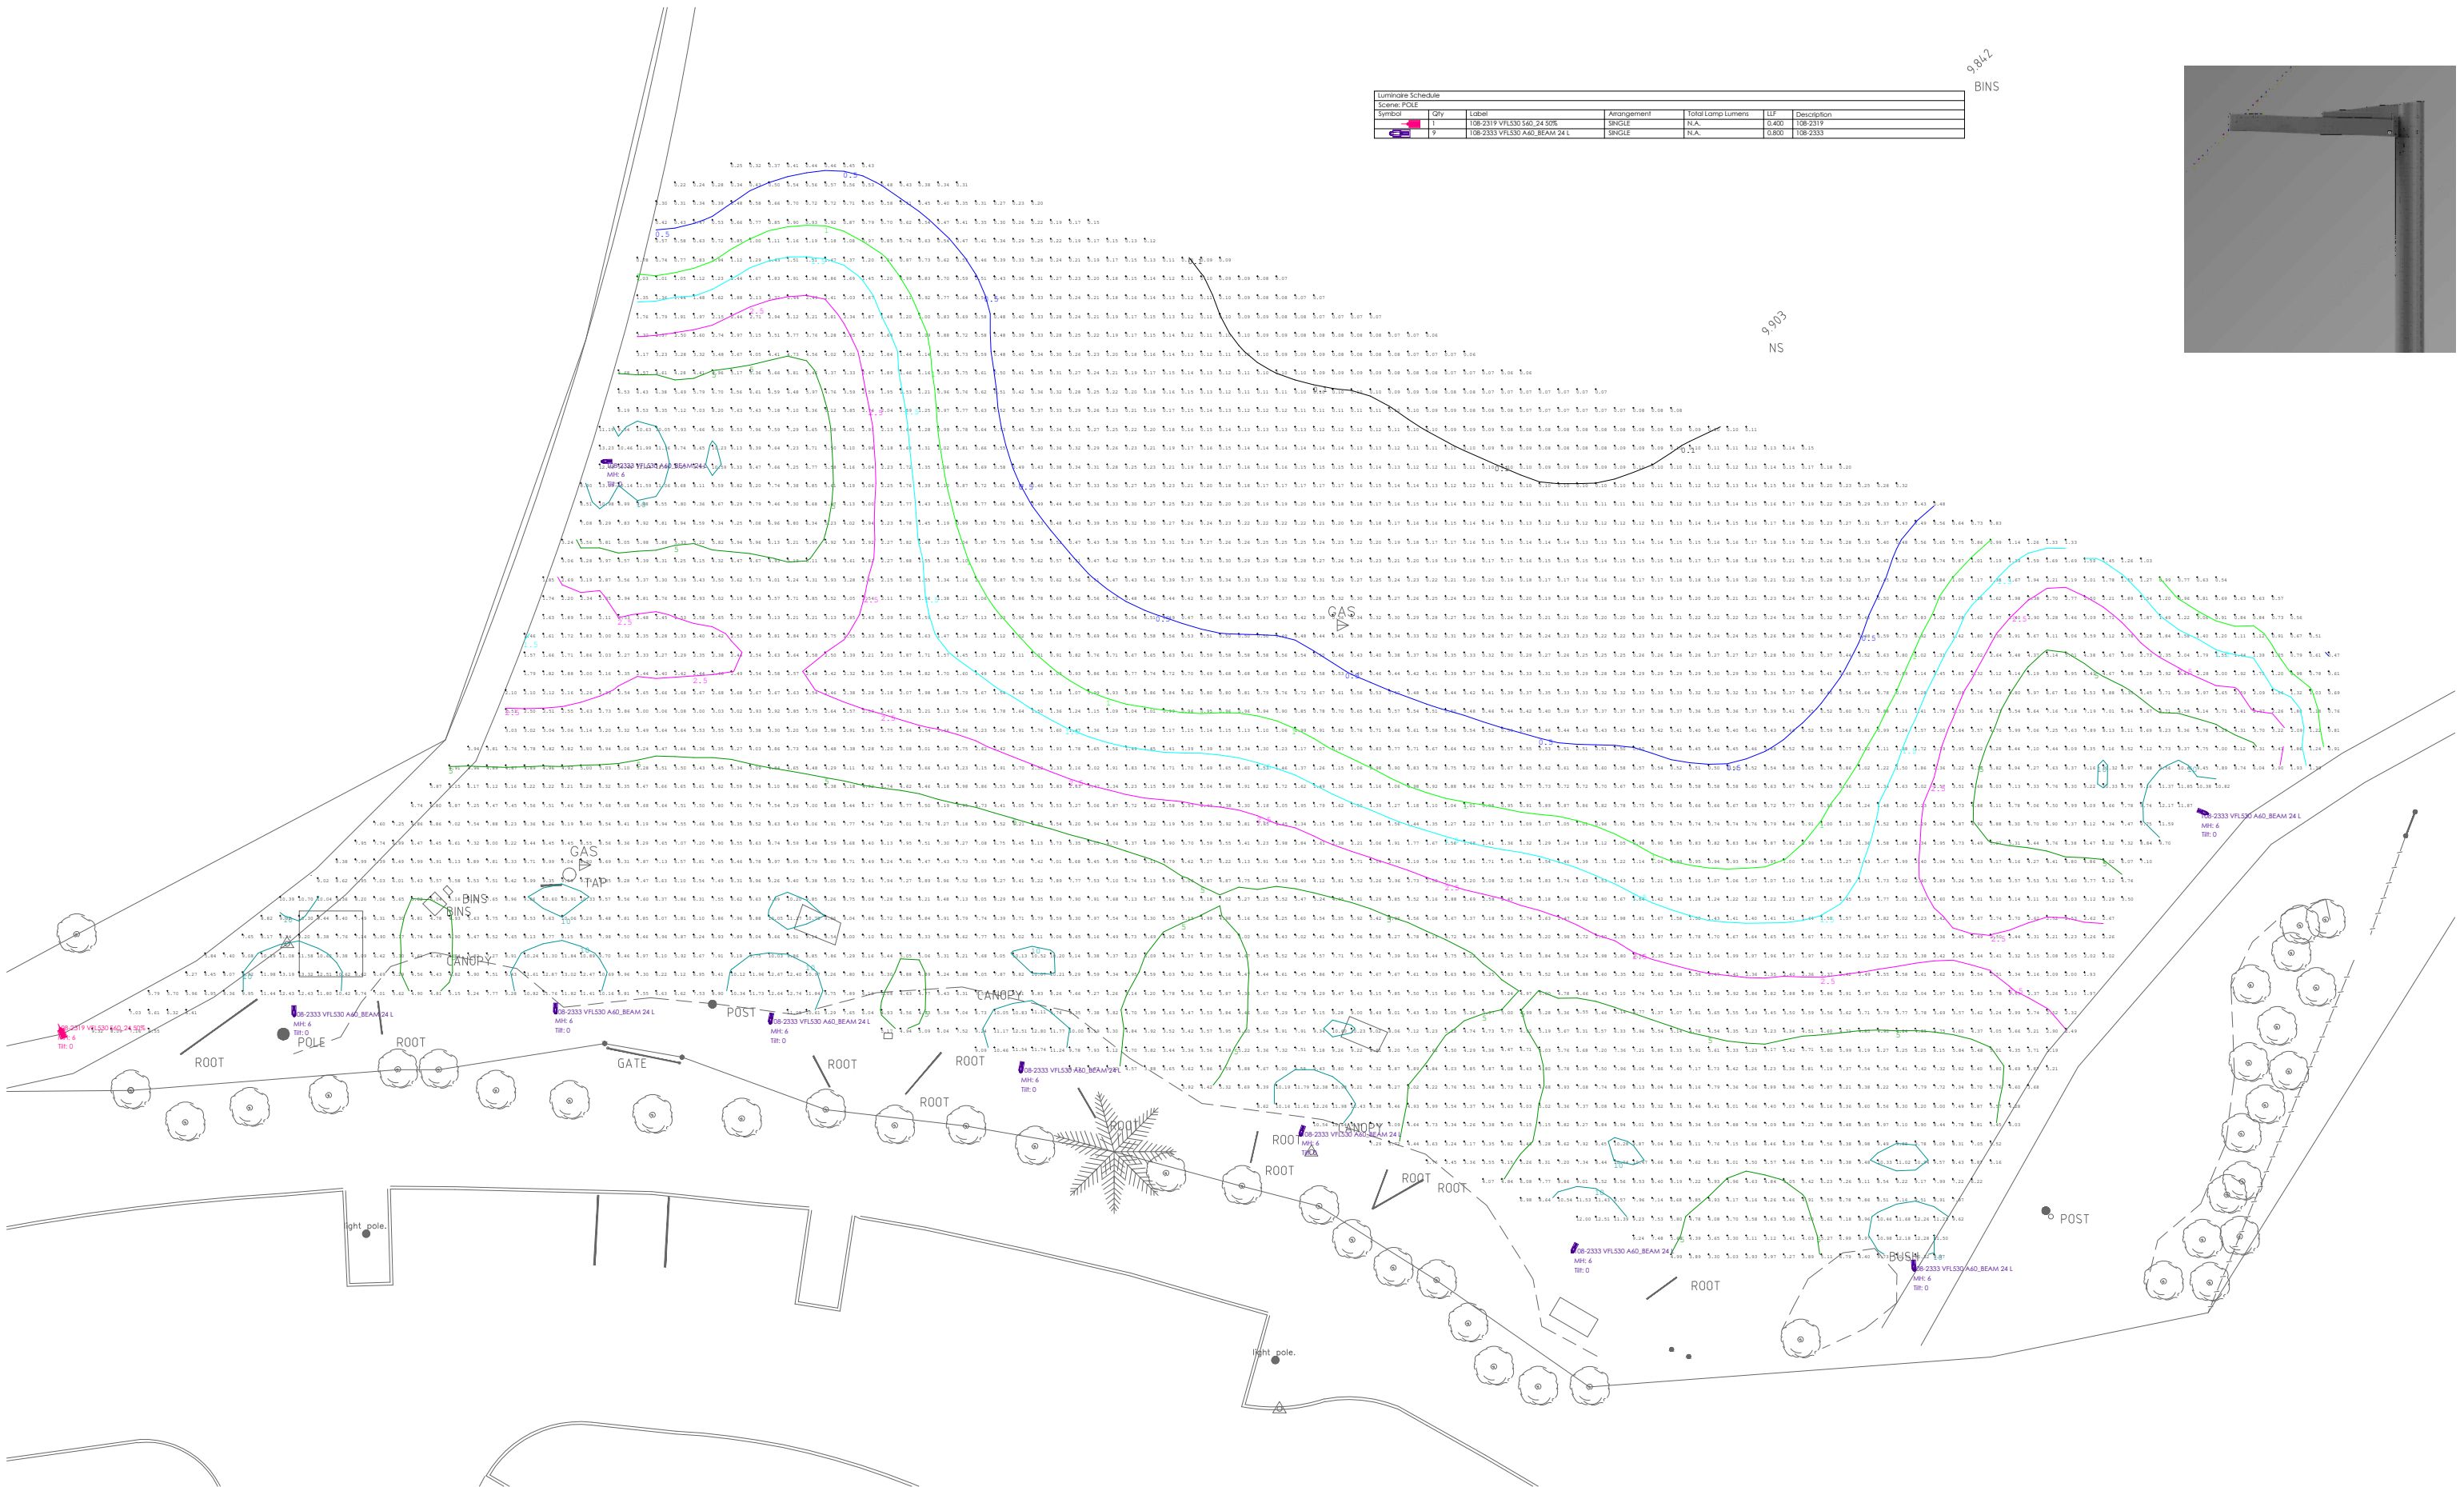

Luminaire Schedule						
Scene: POLE						
Symbol	Qty	Label	Arrangement	Total Lamp Lumens	LF	Description
1	108-2333 VFL530 A60 24 006		SINGLE	N/A.	0.400	108-2333
9	108-2333 VFL530 A60 BEAM 24 L		SINGLE	N/A.	0.800	108-2333

Issue	Amendment
P1	PRELIMINARY ISSUE
P2	REVISED FOR LARGER AREA

Date
12-10-21
20-10-21



NTS@A3

T:\Projects\L170\L170X - Rowland Reserve Dog Off Leash Area\L170X-DG\L170X-SK.dwg - 01 - 20/10/2021 - 11:18:45 AM

Lead Consultant
NBC
Client
NBC



Lighting, Art + Science
Lighting Consultants, Electrical Engineers
Level 1, 41 Hume St, Crows Nest NSW 2065
p: +61 2 9436 0998
e: mail@lands.com.au

Project ROWLAND RESERVE
DOG OFF LEASH AREA
Drawing LIGHTING OPTION 1 - POLES

Drawn RM
Project No
L170X

Approved
Drawing No
SK-01

Date
OCT 2021

Scale
NTS@A3
Rev
P2

© Copyright 2021 Lighting Art & Science Pty Limited ABN 86 152 715 921
All rights reserved. This drawing may not be reproduced or transmitted in any form or means in part or in whole without written permission of Lighting Art & Science Pty Ltd